

ALL WORK TO CONFORM TO THE
B.C.B.C. 2012 Part 9 Small Structures

STRUCTURAL PART 4 SEC 4.1-5
ELECTRICAL SYSTEM CODE:
RESIDENTIAL
MECHANICAL SYSTEM CODE:
PART 6 SFC 6 1-4
PLUMBING SYSTEM CODE
PART 7 SEC. 7 1-8

BUILDING CONTRACTOR/HOME OWNER
TO REVIEW AND VERIFY ALL DIMENSIONS,
SPECS, AND CONNECTIONS BEFORE
CONSTRUCTION BEGINS.

ELECTRICAL SYSTEM CODE: SEC.2701
MECHANICAL SYSTEM CODE: SEC.2801
PLUMBING SYSTEM CODE: SEC.2901

All drawings and related documents
are the copyright of the Architect
and must be returned upon request.
Reproductions of drawings and
related drawings in part or in whole
is forbidden without the Architect's
written permission.

1

NO : DATE : REVISION

REVISION NO :

DESIGNER :

JOB TITLE :

Warehouse Layout

DRAWING :

MAIN and SECOND
FLOORS

DATE : AUG 29 2018

SCALE : as shown

DRAWN BY : A P de L

CHECKED BY:


PROJECT NO.

DRAWING NO.

A-1


REVISION NO.

FILE :

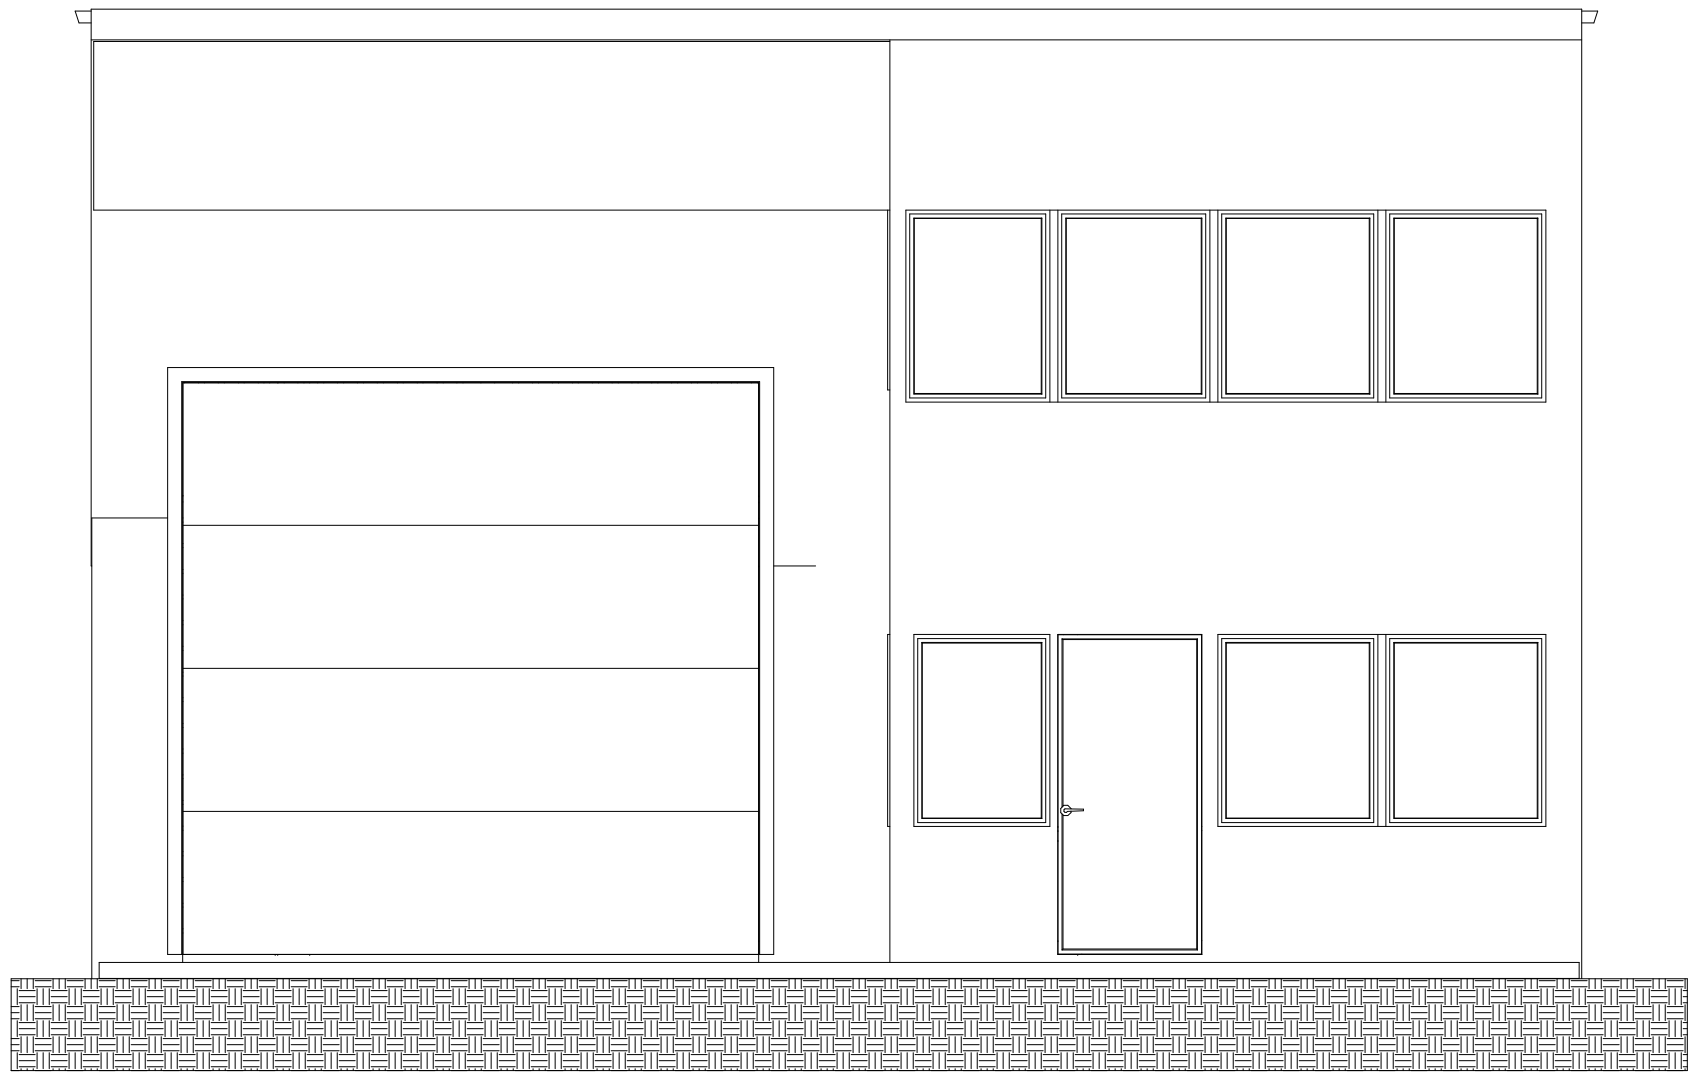


SOUTH ELEVATION

Scale: 1/4" = 1'-0"

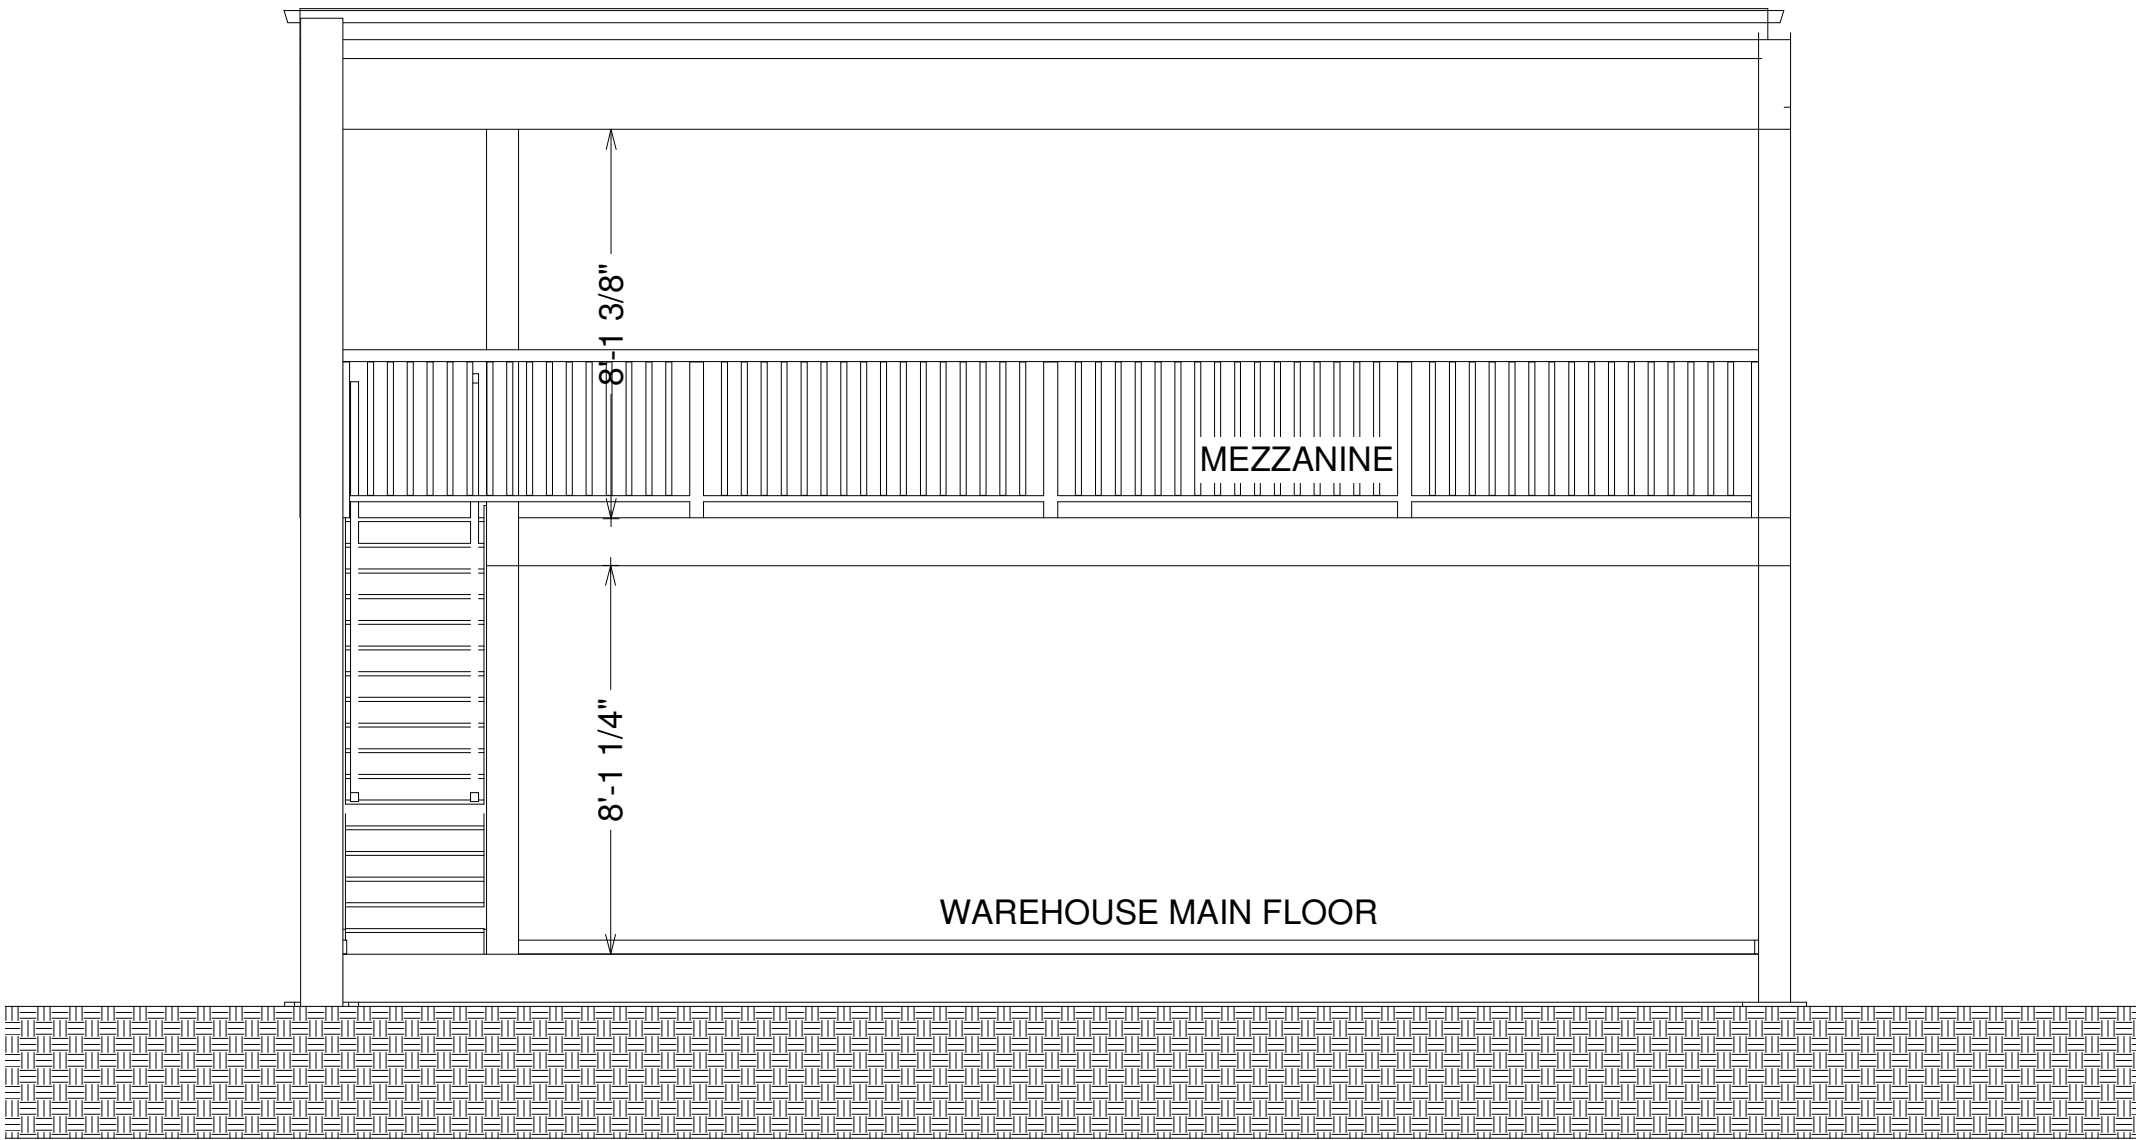

SECTION B-B'

Scale: 1/4" = 1' - 0"

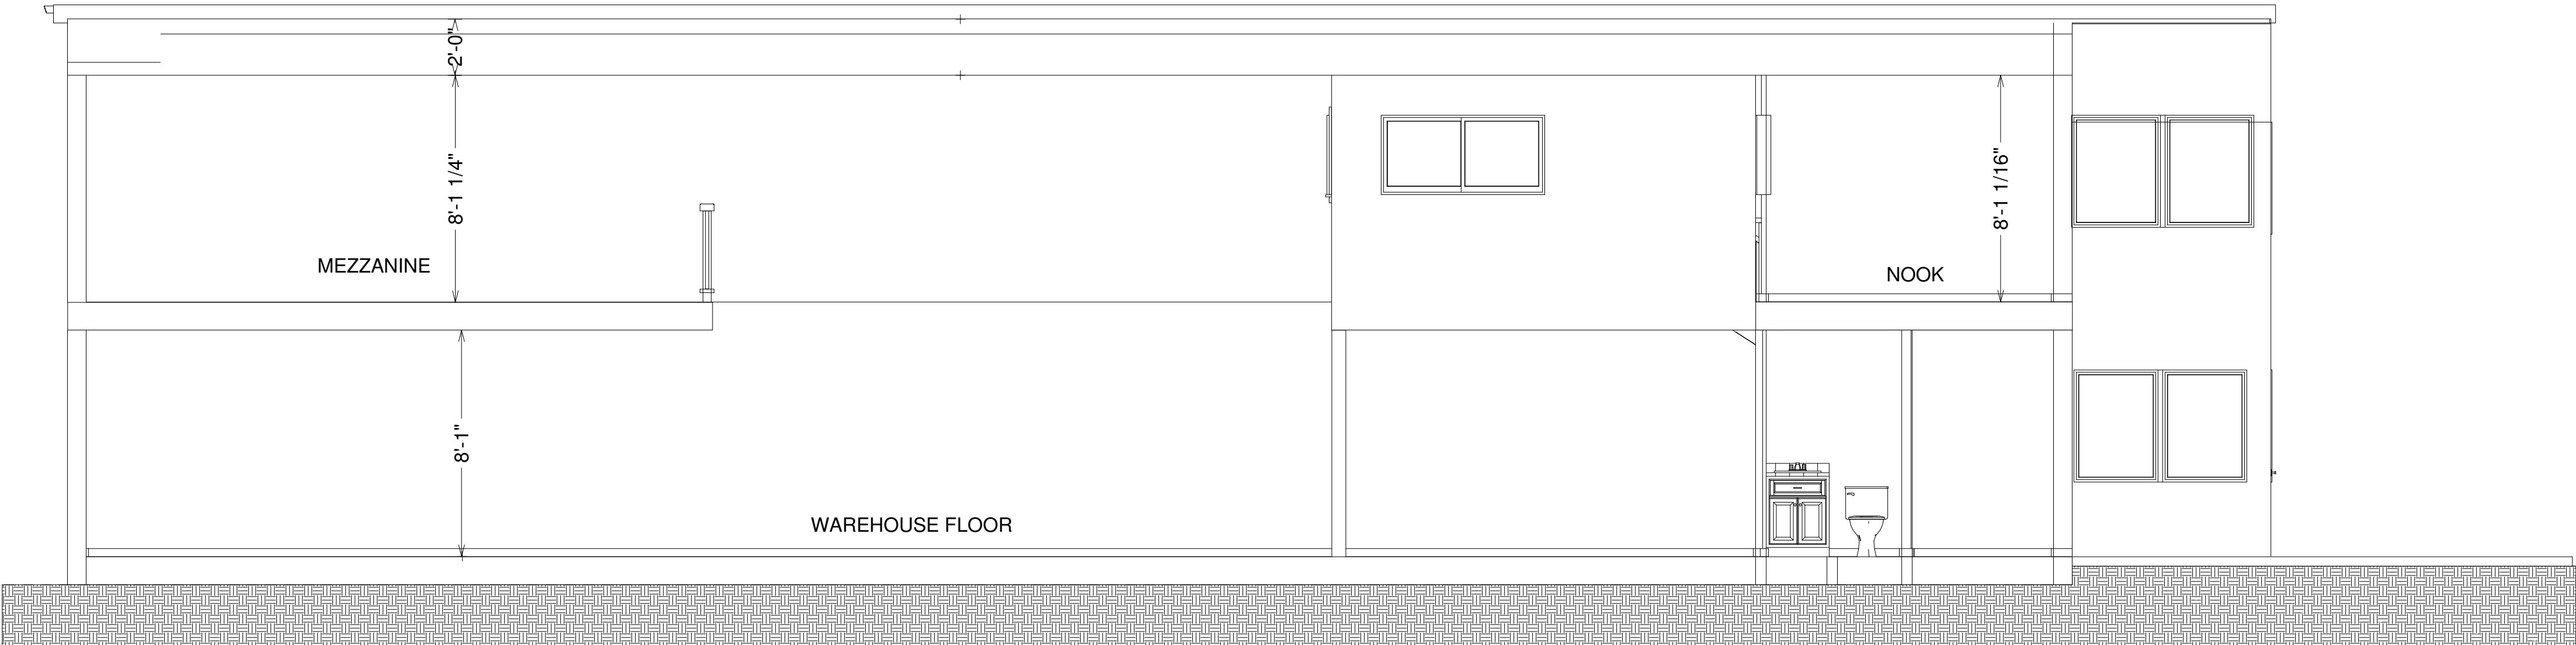

SECTION A-A'

Scale: 1/4" = 1' - 0"

ALL WORK TO CONFORM TO THE
B.C.B.C. 2012 Part 9 Small Structures

STRUCTURAL PART 4 SEC 4.1-5
ELECTRICAL SYSTEM CODE:
RESIDENTIAL
MECHANICAL SYSTEM CODE:
PART 6 SFC 6 1-4
PLUMBING SYSTEM CODE
PART 7 SEC. 7 1-8

BUILDING CONTRACTOR/HOME OWNER
TO REVIEW AND VERIFY ALL DIMENSIONS,
SPECS, AND CONNECTIONS BEFORE
CONSTRUCTION BEGINS.

ELECTRICAL SYSTEM CODE: SEC.2701
MECHANICAL SYSTEM CODE: SEC.2801
PLUMBING SYSTEM CODE: SEC.2901

All drawings and related documents
are the copyright of the Architect
and must be returned upon request,
Reproductions of drawings and
related drawings in part or in whole
is forbidden without the Architect's
written permission.

| | | |
|---------------|--------|----------|
| 1 | | |
| NO : | DATE : | REVISION |
| REVISION NO : | | |

NWI Contracting Ltd.

1740 Broadway St # 4
Port Coquitlam, BC
V3C 2M8 Canada

DESIGNER :

APL Design Studio

JOB TITLE :

Warehouse Layout

DRAWING :

MAIN FLOOR

| | |
|--------------|-------------|
| DATE : | AUG 29 2018 |
| SCALE : | as shown |
| DRAWN BY : | A P de L |
| CHECKED BY: | |
| PROJECT NO. | DRAWING NO. |
| | A-2 |
| REVISION NO. | FILE : |